


- LIGHT SCHEDULE**
- RECESSED WALL WASHER =
 - RECESSED DOWN LIGHT =
 - RECESSED 2X4 FLUORESCENT =
 - SURFACE 2X4 FLUORESCENT =
 - CHANDELIER =
 - UNDER COUNTER FLUORESCENT =
 - COACH LANTERN - WALL MOUNT =
 - WALL SCONCE =



APPROX. LOCATION OF ABOVE
CEILING TV MOUNT. VERIFY SIZE &
LOCATION W/ ARCHITECT. TRIM
OPENING W/ 1X4 AZEK TRIM

CL OF
FURDOWN
= CL OF
COLUMNS

0.4 1st FLOOR REFLECTED CEILING PLAN
SCALE= 1/8" = 1'-0"

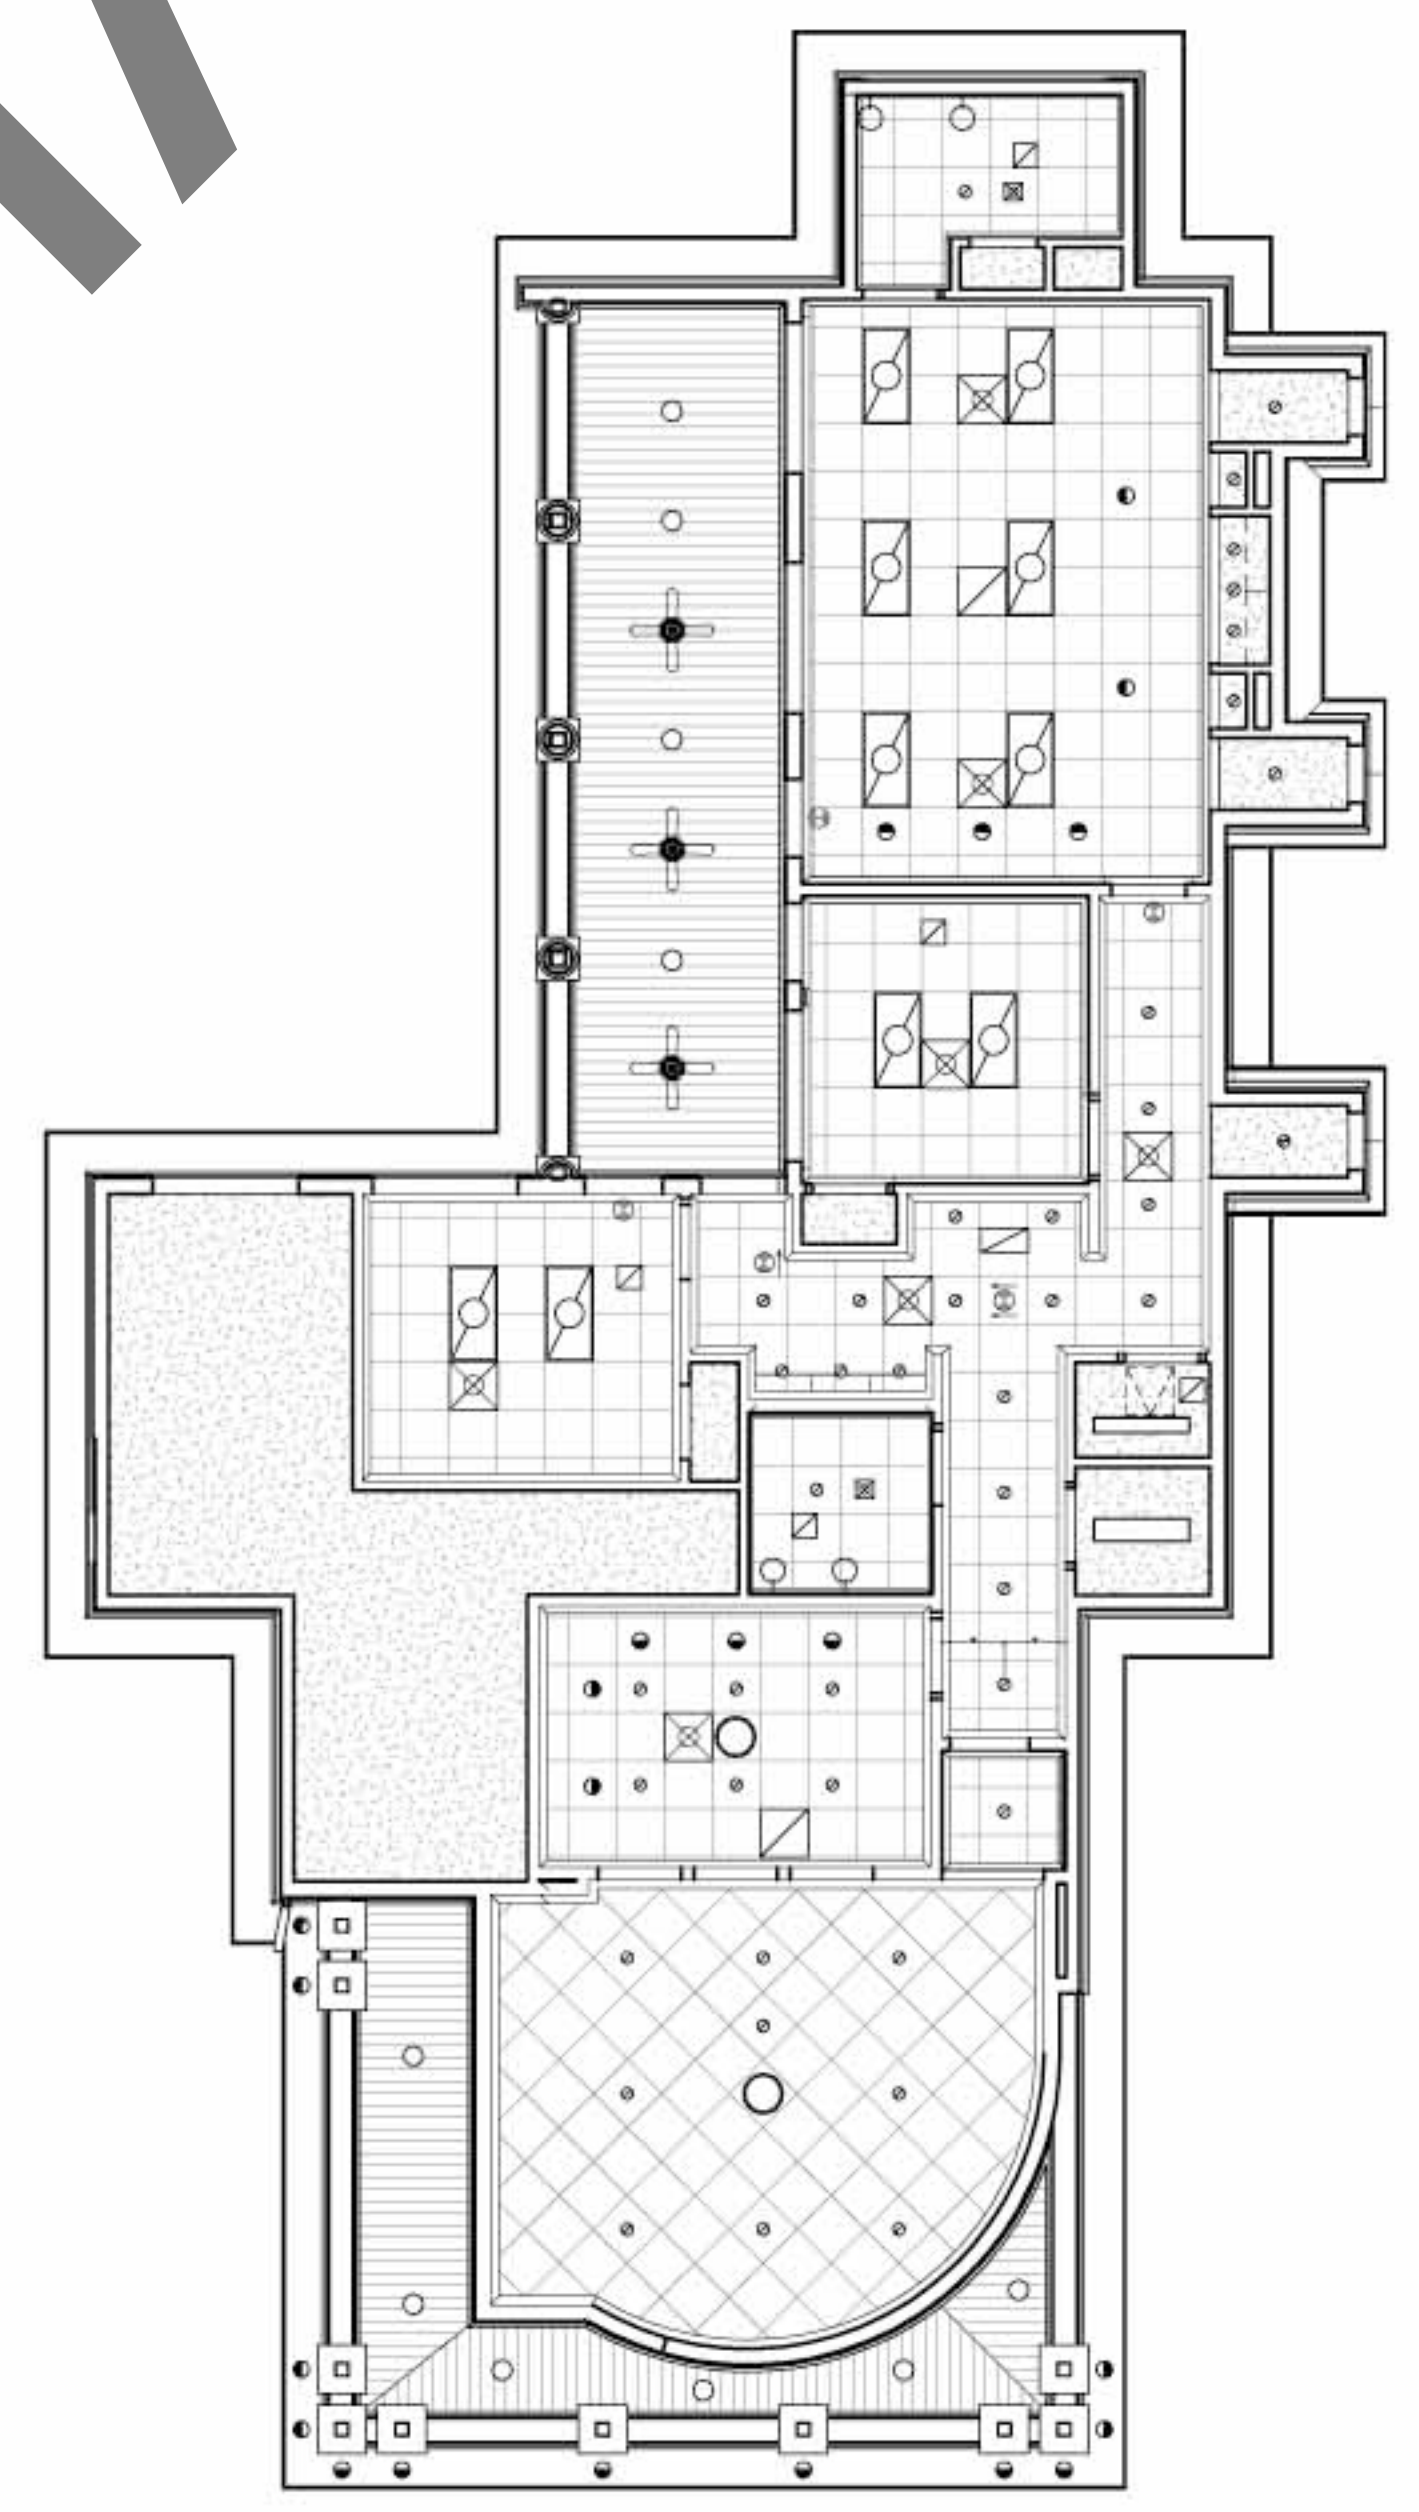

0.8 2nd FLOOR REFLECTED CEILING PLAN
SCALE= 1/8" = 1'-0"

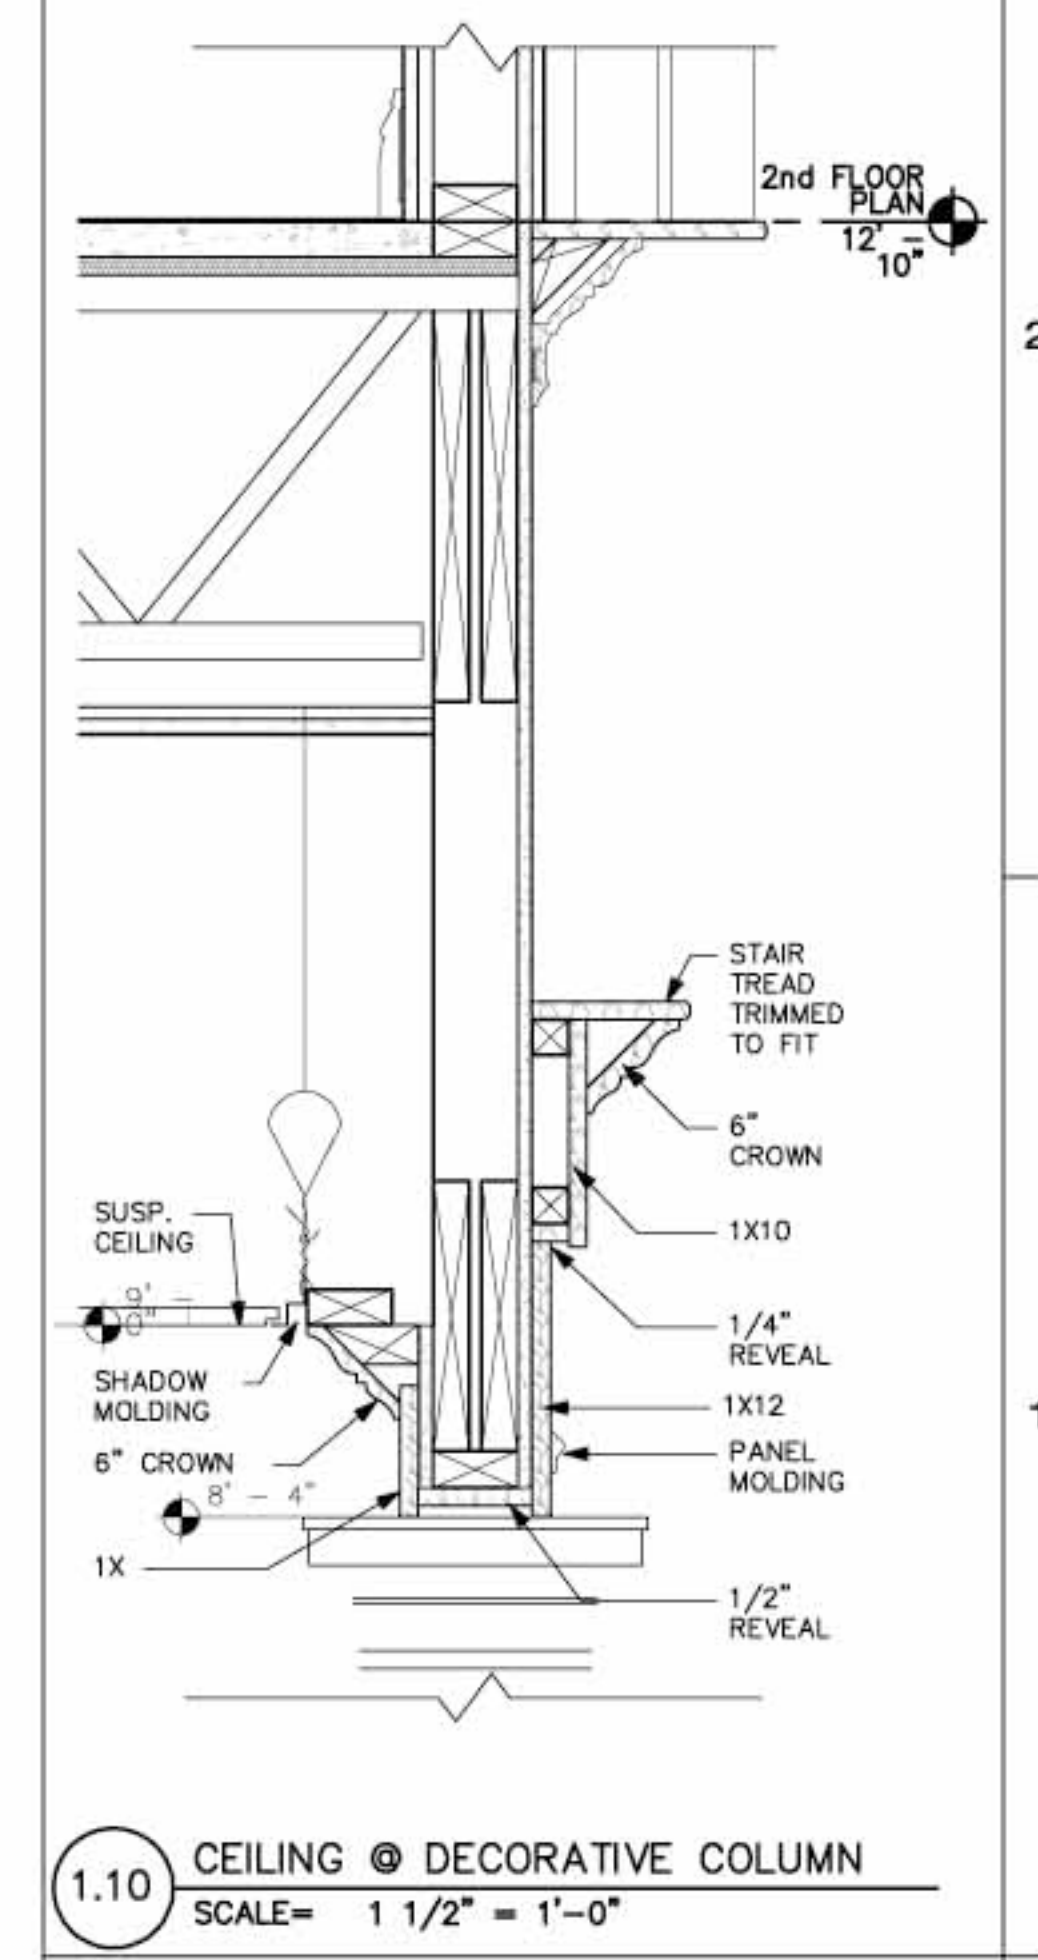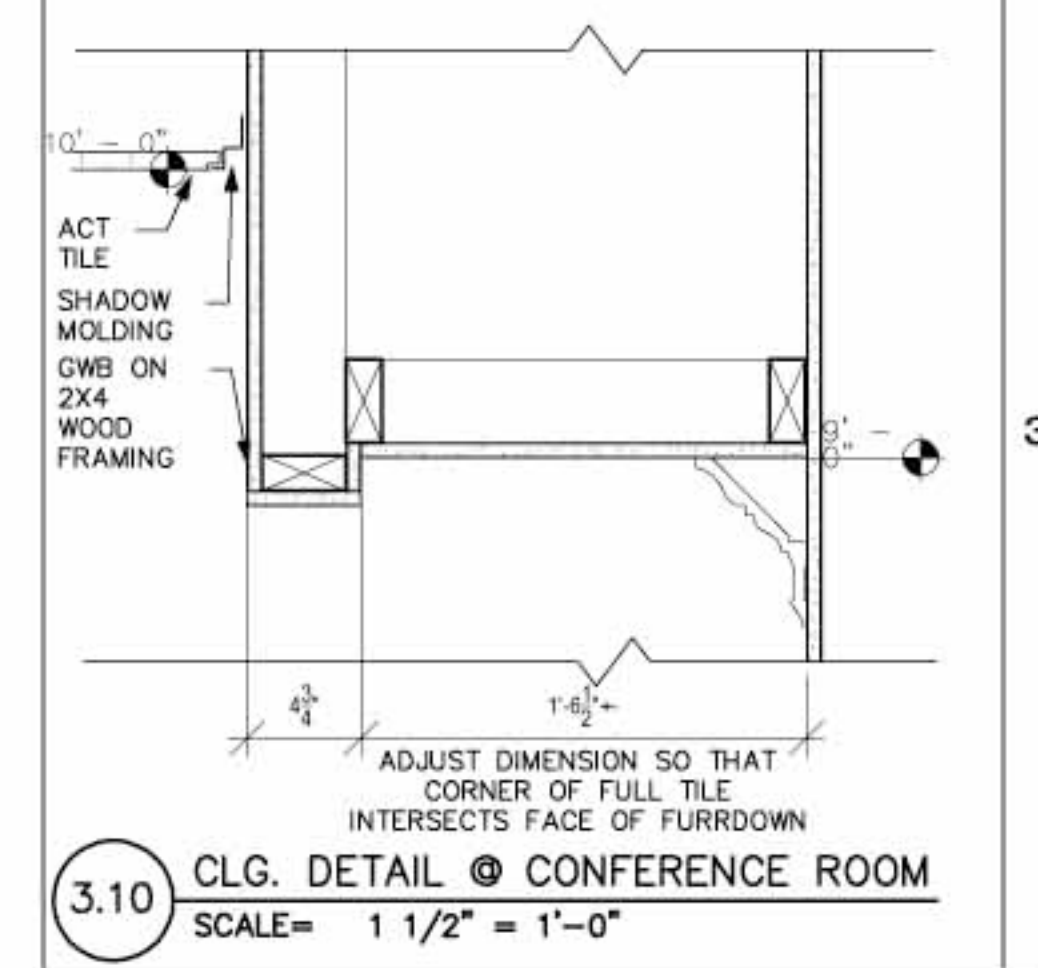

REVISIONS		DATE	OCTOBER, 2009
NO.	DATE	PROJ. NO.	0905
		SHEET	A1.2
		OF	SHEETS