



- GENERAL NOTES**
1. ANY EXPOSED STRUCTURE, MECHANICAL, PLUMBING, ELECTRICAL AND ASSOCIATED COMPONENTS AND CEILING SYSTEM ACCESSORIES SHALL BE PAINTED GLOSS BLACK IN PUBLIC AREAS - REFERENCE SPECIFICATION D1900 FOR EXACT COLOR IN PUBLIC AND NON-PUBLIC AREAS.
 2. THE CONTRACTOR SHALL PROVIDE CUTOUTS AND OTHER SPECIAL PROVISIONS IN CEILING SYSTEM WORK AS REQUIRED FOR LIGHT FIXTURES, DIFFUSERS, REGISTERS AND OTHER INSERTED ITEMS.
 3. PRIOR TO CLOSING UP ANY CEILING, ALL PLENUM SYSTEMS (PLUMBING, HVAC, AND ELECTRICAL) SHALL BE INSPECTED AND TESTED BY CONTRACTORS, ENGINEERS, AND BY AUTHORITIES HAVING JURISDICTION TO ENSURE THEIR PROPER INSTALLATION AND FUNCTION.
 4. REFERENCE MECHANICAL, ELECTRICAL, AND PLUMBING DRAWINGS FOR SIZE AND QUANTITY OF EQUIPMENT. REFERENCE ARCHITECTURAL DRAWINGS FOR LOCATION AND MOUNTING HEIGHTS OF LIGHT FIXTURES AND DIFFUSERS ETC.
 5. PROVIDE ALL MISCELLANEOUS STEEL AS REQUIRED FOR THE PROPER INSTALLATION OF ELECTRICAL EQUIPMENT, LIGHT FIXTURES, LIGHTING GRIDS AND SYSTEMS, INCLUDING, BUT NOT LIMITED TO SUPPORTS, ANCHORS, AND GUIDES. SUBMIT PROPOSED METHODS FOR SUPPORTING ELECTRICAL AND MECHANICAL SYSTEMS AND EQUIPMENT TO THE STRUCTURAL ENGINEER FOR APPROVAL.
 6. COORDINATE WITH ARCHITECTURAL DRAWINGS FOR EXACT HEIGHT AND LOCATION OF LIGHT FIXTURES AND SPECIALTY COMPONENTS. THE CONTRACTOR SHALL COORDINATE WITH THAT OF THE FIRE PROTECTION, HVAC, PLUMBING, AND ELECTRICAL CONTRACTORS WHENEVER THEIR WORK IS CONTIGUOUS. ANY DISCREPANCIES SHALL BE BROUGHT TO THE ATTENTION OF THE ARCHITECT.
 7. GENERAL CONTRACTOR SHALL COORDINATE WITH DRYWALL/MILLWORK CONTRACTOR AND ELECTRICAL CONTRACTOR IN COORDINATING OPENINGS FOR LIGHT FIXTURES AND SIZE OF LIGHT FIXTURES REQUIREMENTS.
 8. GENERAL CONTRACTOR SHALL COORDINATE WITH ARCHITECT AND ELECTRICAL CONTRACTOR PRIOR TO THE INSTALLATION OF ALL TRANSFORMERS. TRANSFORMERS TO LIGHT FIXTURES SHALL BE LOCATED ABOVE THE IMMEDIATE ADJACENT LAY-IN CEILING SYSTEM OR EXPOSED AREA.
 9. REF. LIGHT FIXTURE SCHEDULE FOR SPECIAL NOTES REGARDING LIGHT FIXTURES.
 10. REF. INDEX SHEET FOR GENERAL NOTES.

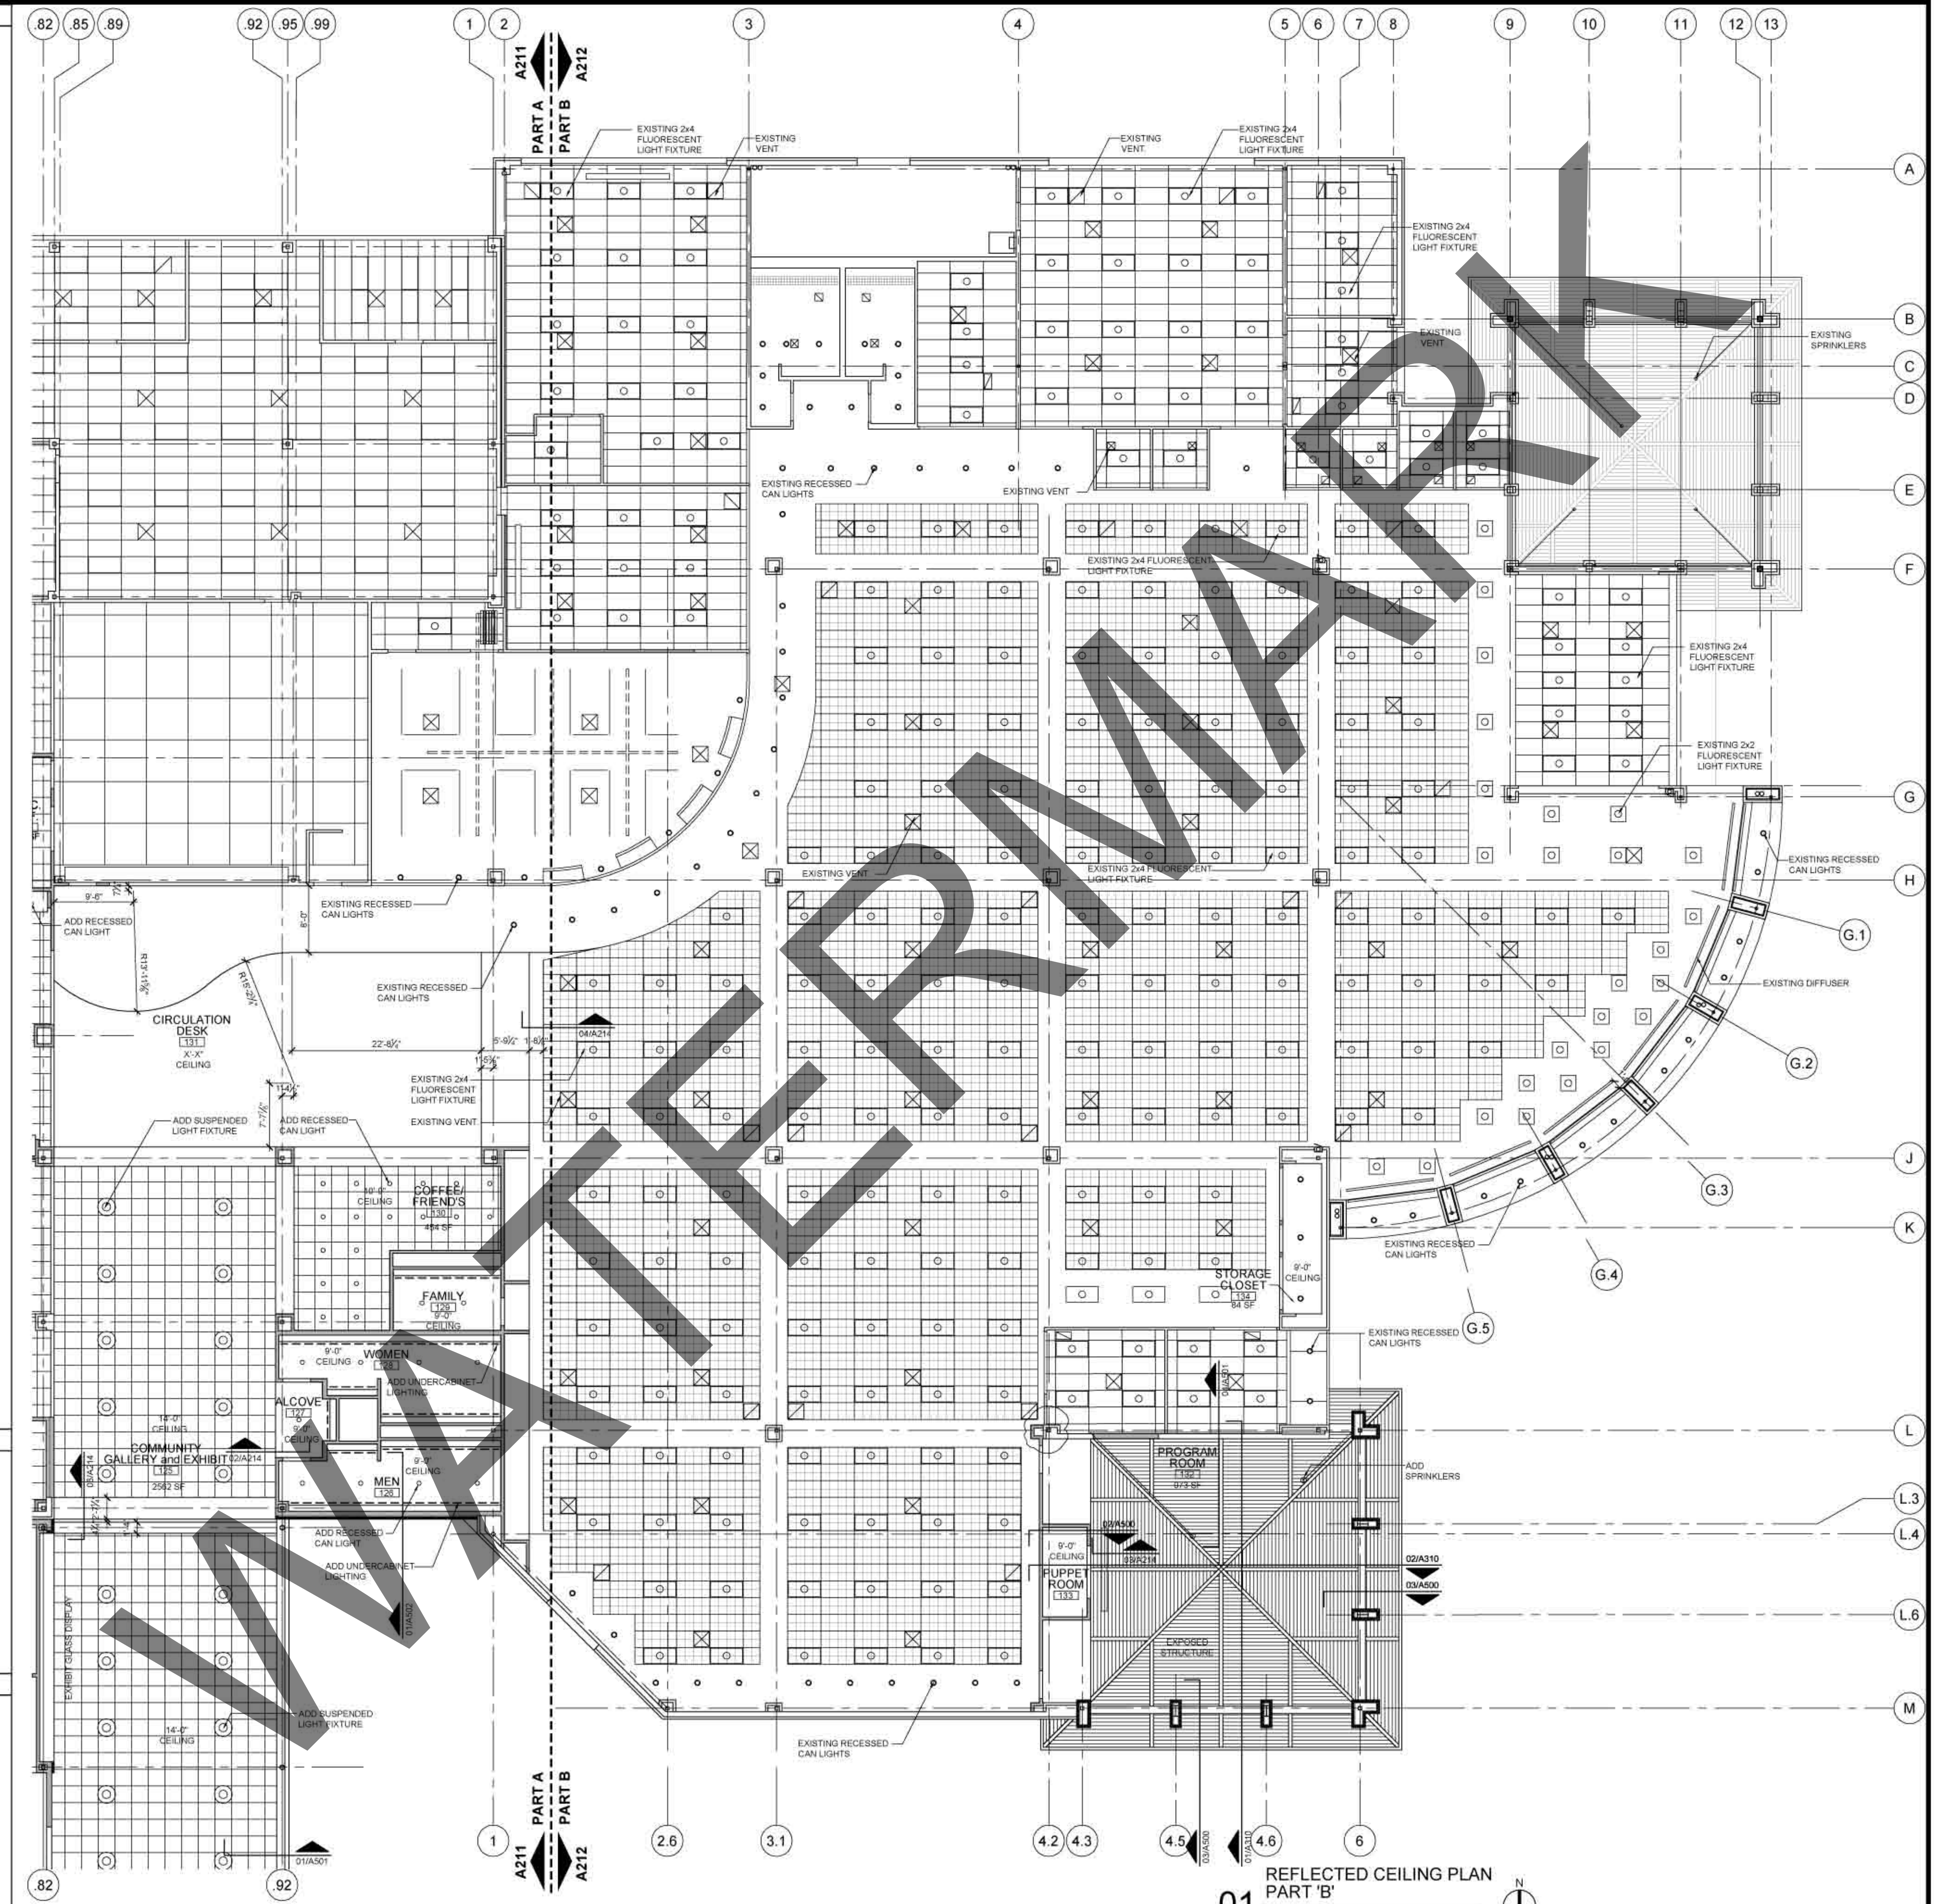

- LIGHT FIXTURE LEGEND**
- 2x2 FLUORESCENT LIGHT FIXTURE
 - RECESSED CAN LIGHT
 - ⊙ SUSPENDED LIGHT FIXTURE AS SCHEDULED
 - ⊞ SUSPENDED LIGHT FIXTURE AS SCHEDULED
 - UNDERCABINET LIGHTING AS SCHEDULED
 - SURFACE-WALL MOUNTED LIGHT FIXTURE AS SCHEDULED
 - TRACK LIGHTING SYSTEM
 - ▤ 2' x 7' ACOUSTICAL LAY-IN CEILING
 - ⊞ SUPPLY AIR DIFFUSER-HORIZONTAL
 - SLOT DIFFUSER
 - ⊞ SUPPLY AIR DIFFUSER
 - ⊞ RETURN AIR GRILLE
 - ⊞ SPEAKER

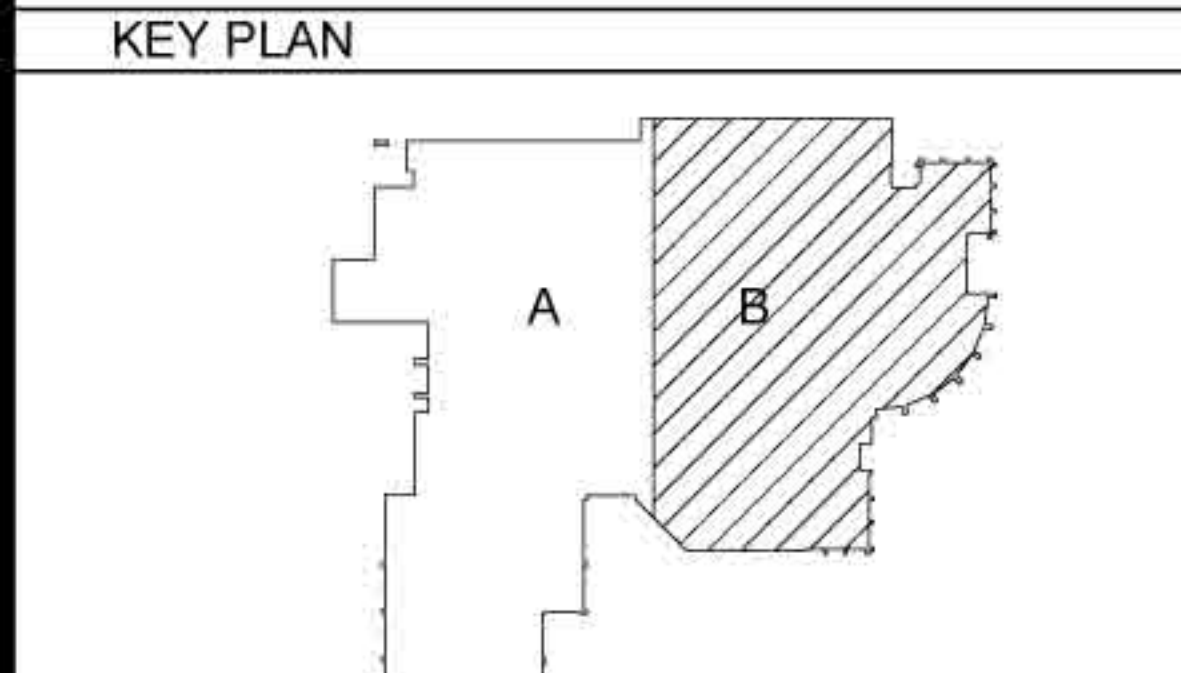

01 REFLECTED CEILING PLAN PART 'B'
1/8" = 1'-0"

JOB NO. 28000
 Issue Date: 06/19/2009
 Drawn By: DZ
 Checked By: TB
 SHEET NO.

A212